


NOTES:

- 1 NEW 100 AMPERE - 3W PLUG-IN BUS DUCT - FEDERAL PACIFIC
- 2 EXISTING 400 AMPERE - 3W PLUG-IN BUS DUCT - FEDERAL PACIFIC
- 3 PROVIDE REQUIRED FITTINGS & SECTIONS TO RELOCATE 400 AMPERE BUS DUCT AS SHOWN. RECONNECT TRANSFORMER TO RELOCATED DUCT.
- 4 RELOCATE 2" 1/4" CONDUITS UP TO CLEAR NEW OPENING.
- 5 EXISTING LIGHTING FIXTURES RELOCATED FROM EXISTING BUILDING AND RECONNECTED TO EXISTING CIRCUITS.
- 6 TO EXISTING - PANEL 'O' - PROVIDE 1-1P-20 AMP CIRCUIT BREAKER IN SPACE 'B' - PROVIDE A PARAGON 4004-275E TIME CLOCK AND WIRE THIS CIRCUIT THRU CLOCK.
- 7 CONNECT TO NEAREST EXIT LIGHT
- 8 EXTEND WIRING FOR RELOCATED HVAC UNITS.
- 9 95 KVA TRANSFORMER - 480V - PRIMARY 120V - 208Y - 55C - 3-#4 - 1" C - TO 100 AMPERE BUS DUCT PLUG-IN - SW, AND 4-#1 - 1 1/2" C TO PANEL.

APPROVED
DIRECTOR - CONSTRUCTION
ELECTRICAL
MECHANICAL
CONSTRUCTION
FINANCE
ISSUED

RECEIVED
DEPT. OF HOUSING
AND COMMUNITY
DEVELOPMENT
JUN 3 1960
No. 485

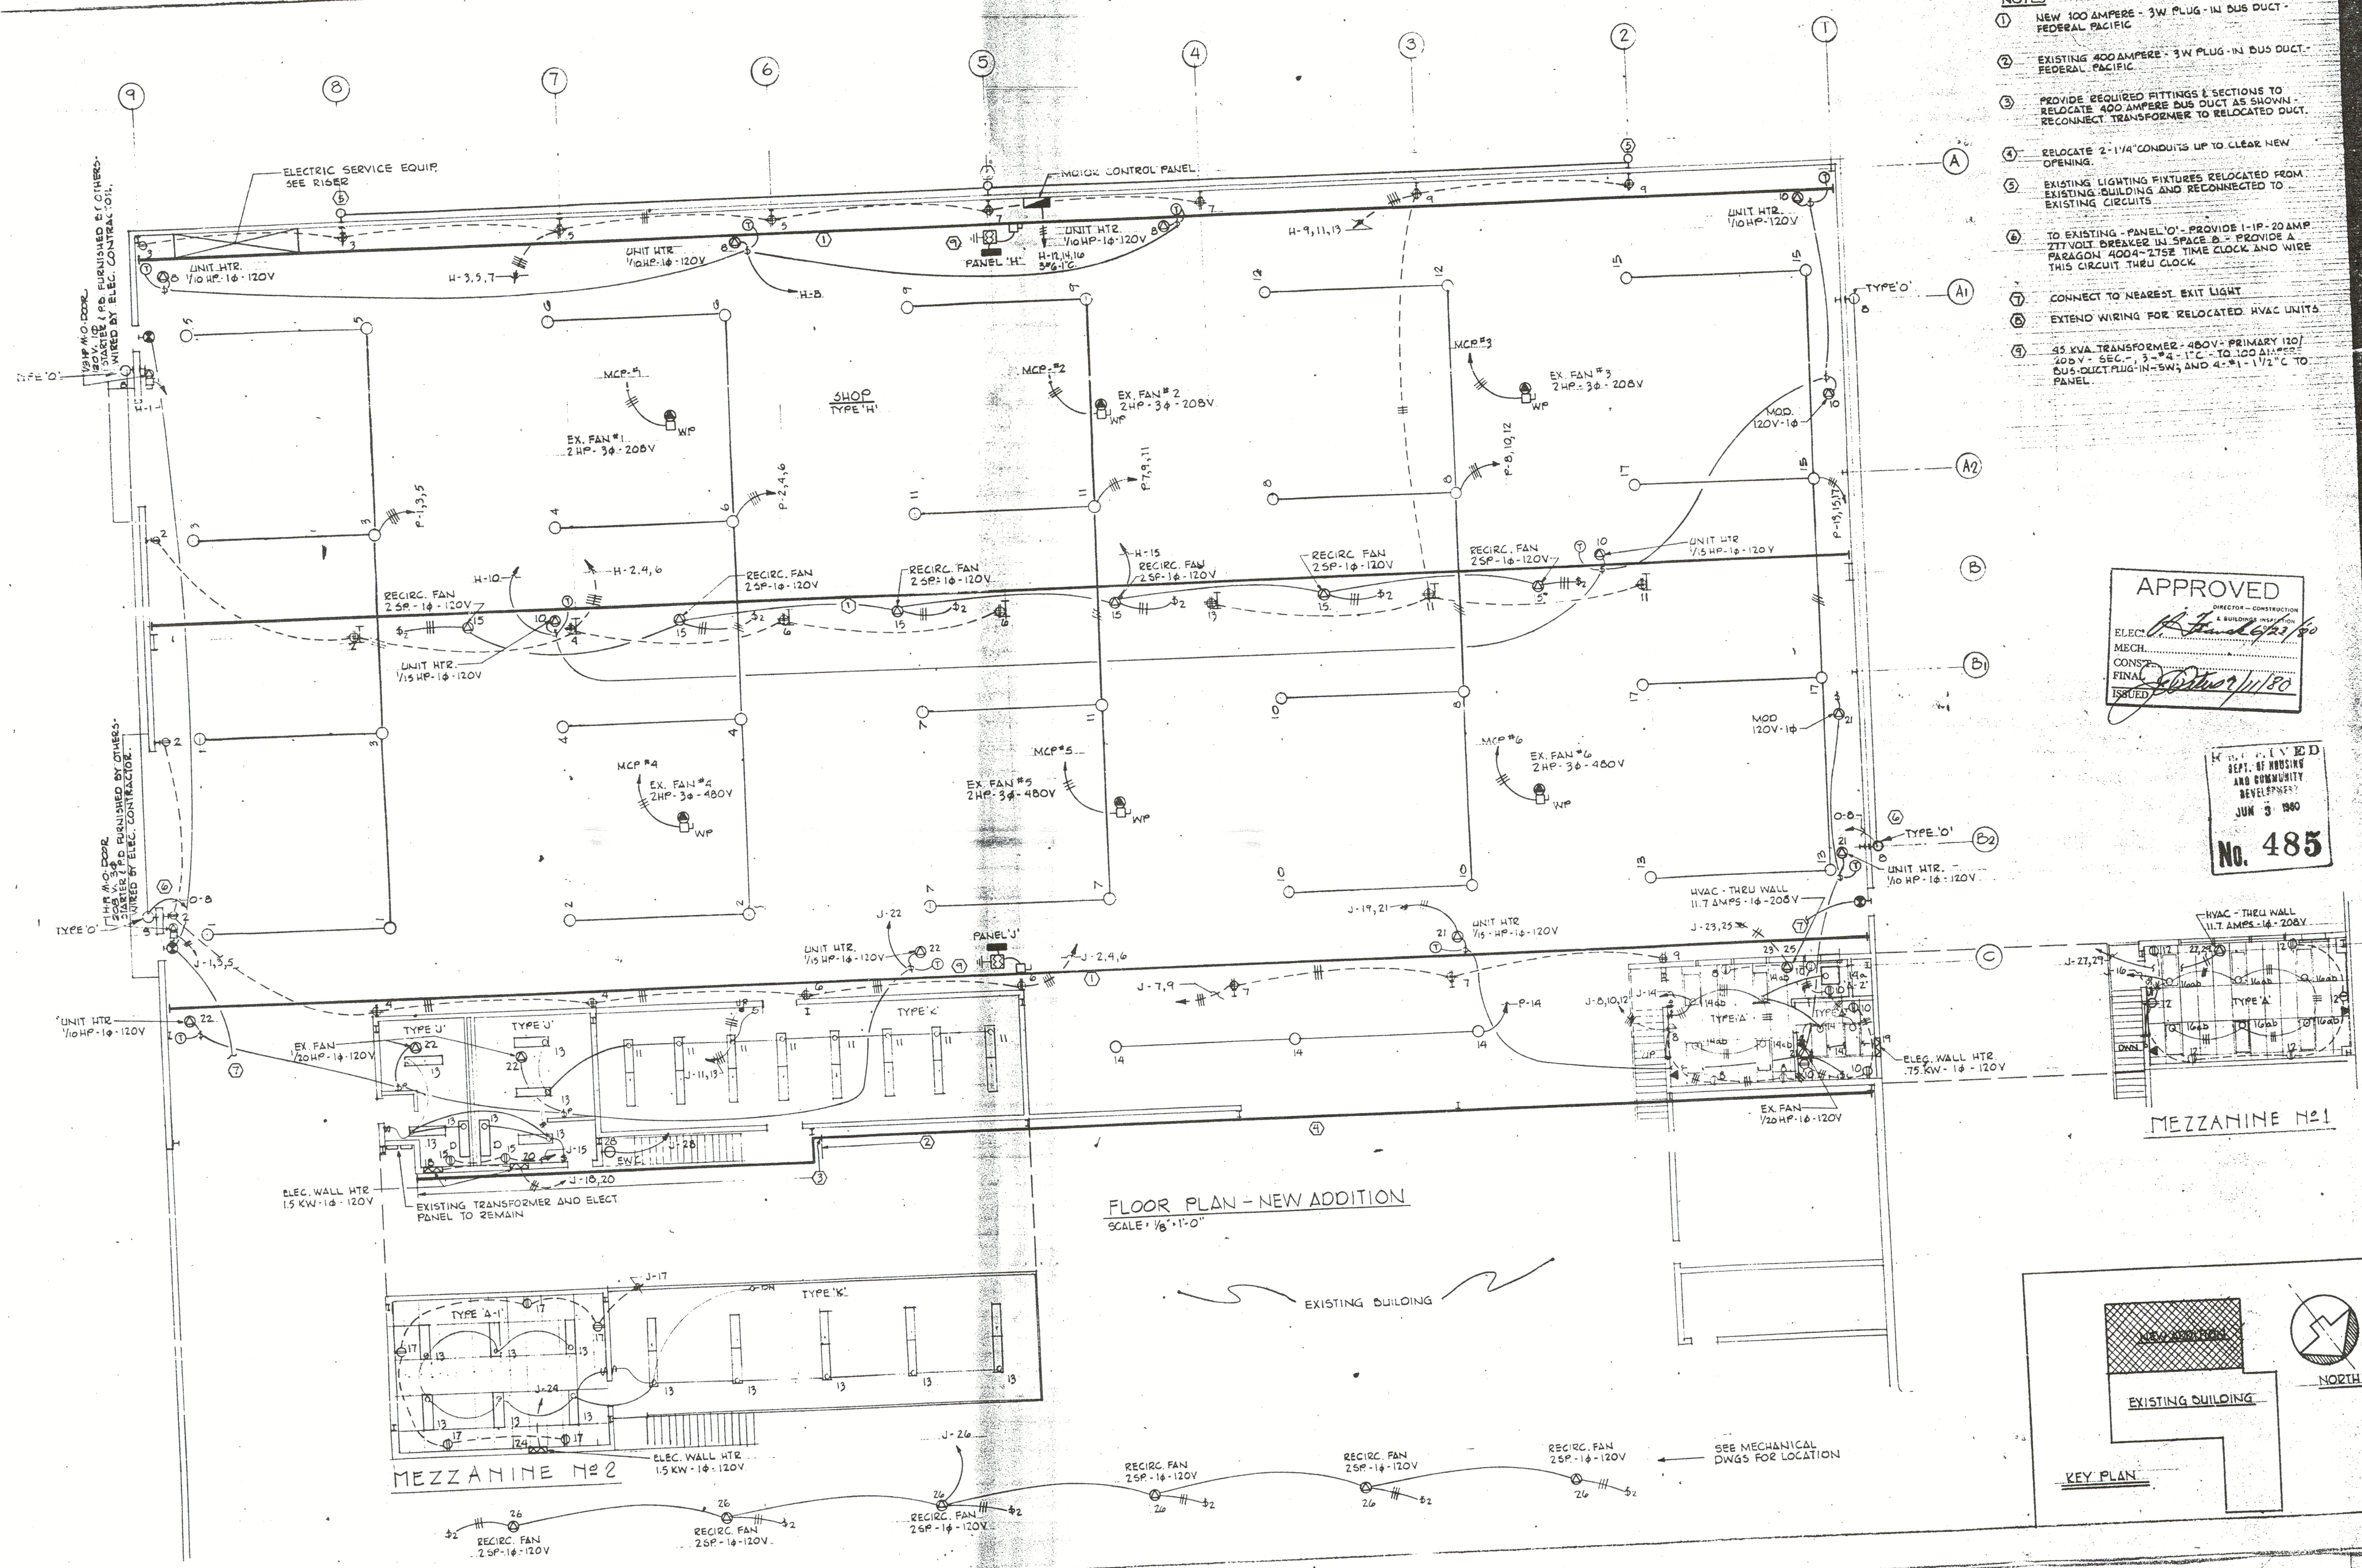

FLOOR PLAN - NEW ADDITION
SCALE: 1/8" = 1'-0"

